





NOTES

1. ALL DIMENSIONS ARE IN MM UNLESS OTHERWISE STATED.

AS-BUILT

0	22/01/16	AS-BUILT	SS	AM		
REV.	DATE	DESCRIPTION	DRAWN	CHK'D	APP'VD	APP'VD
			CONSULTANT	CONSULTANT	CLIENT	CLIENT


**PETROCHEMICAL ENGINEERING CONSULTANTS**  
C-2, BLOCK NO. 17, GULSHAN-E-IGBAL, NEAR NATIONAL STADIUM, KARACHI-75300, PAKISTAN.  
TEL: +92 (21) 34827780, 34961088, FAX: +92 21 34961089, E-Mail: contact@pec.com.pk web site: www.pec.com.pk

CLIENT**OIL & GAS DEVELOPMENT COMPANY LTD.**

PROJECT**AS BUILT OF DAKHNI & SOGHARI WELLHEADS,  
PLANT INLET & STORAGE AREA**

TITLE**WELLHEAD DAKHNI-08  
KEY PLAN**


DRAWING NO.		SHEET	SCALE	REV.
2579-PL-601		NO. OF	1:400	
		1 4	A3	0

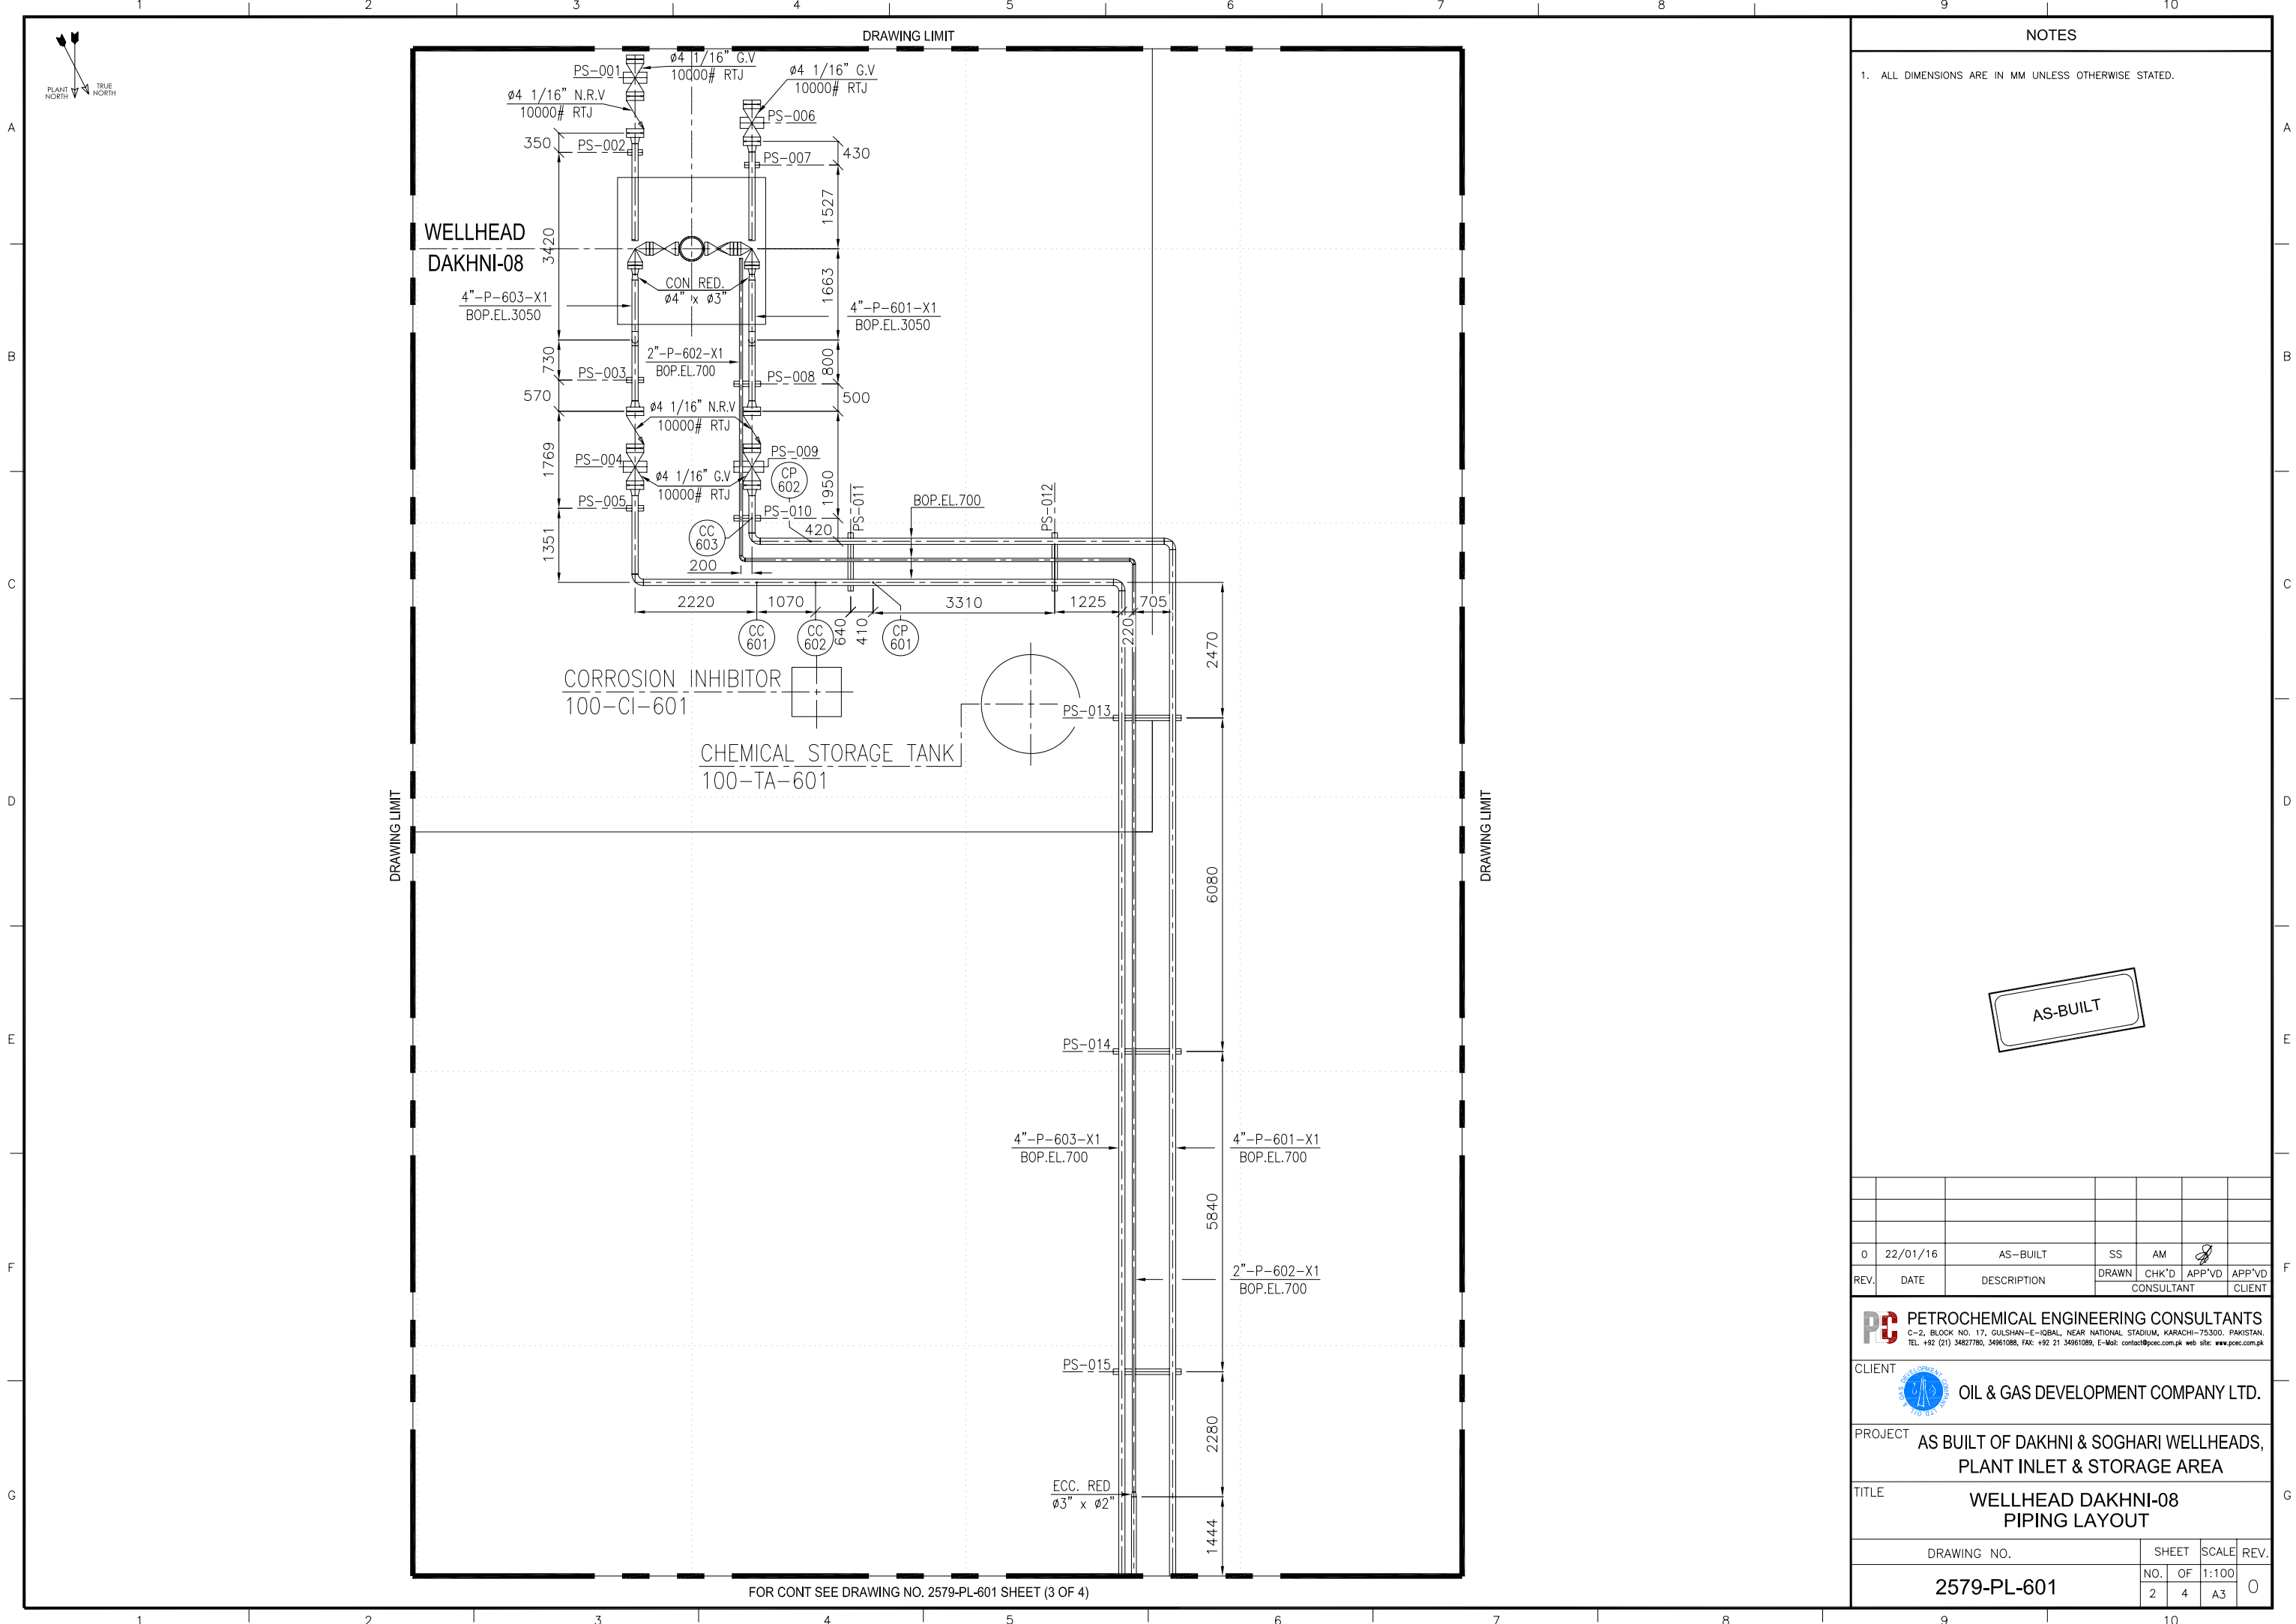


NOTES

1. ALL DIMENSIONS ARE IN MM UNLESS OTHERWISE STATED.

AS-BUILT

0	22/01/16	AS-BUILT	SS	AM					
REV.	DATE	DESCRIPTION	DRAWN	CHK'D	APP'VD	APP'VD			
			CONSULTANT			CLIENT			
<div><div>PC</div><div>PETROCHEMICAL ENGINEERING CONSULTANTS</div><div>C-2, BLOCK NO. 17, GULSHAN-E-IGBAL, NEAR NATIONAL STADIUM, KARACHI-75300, PAKISTAN.</div><div>TEL: +92 (21) 34827780, 34961088, FAX: +92 21 34961089, E-Mail: contact@ppec.com.pk web site: www.ppec.com.pk</div></div>									
<div>CLIENT<div>OIL &amp; GAS DEVELOPMENT COMPANY LTD.</div></div>									
<div>PROJECTAS BUILT OF DAKHNI &amp; SOGHARI WELLHEADS, PLANT INLET &amp; STORAGE AREA</div>									
<div>TITLEWELLHEAD DAKHNI-08 PIPING LAYOUT</div>									
DRAWING NO.				SHEET	SCALE	REV.			
2579-PL-601				NO. OF	1:100				
				2	4	A3	0		

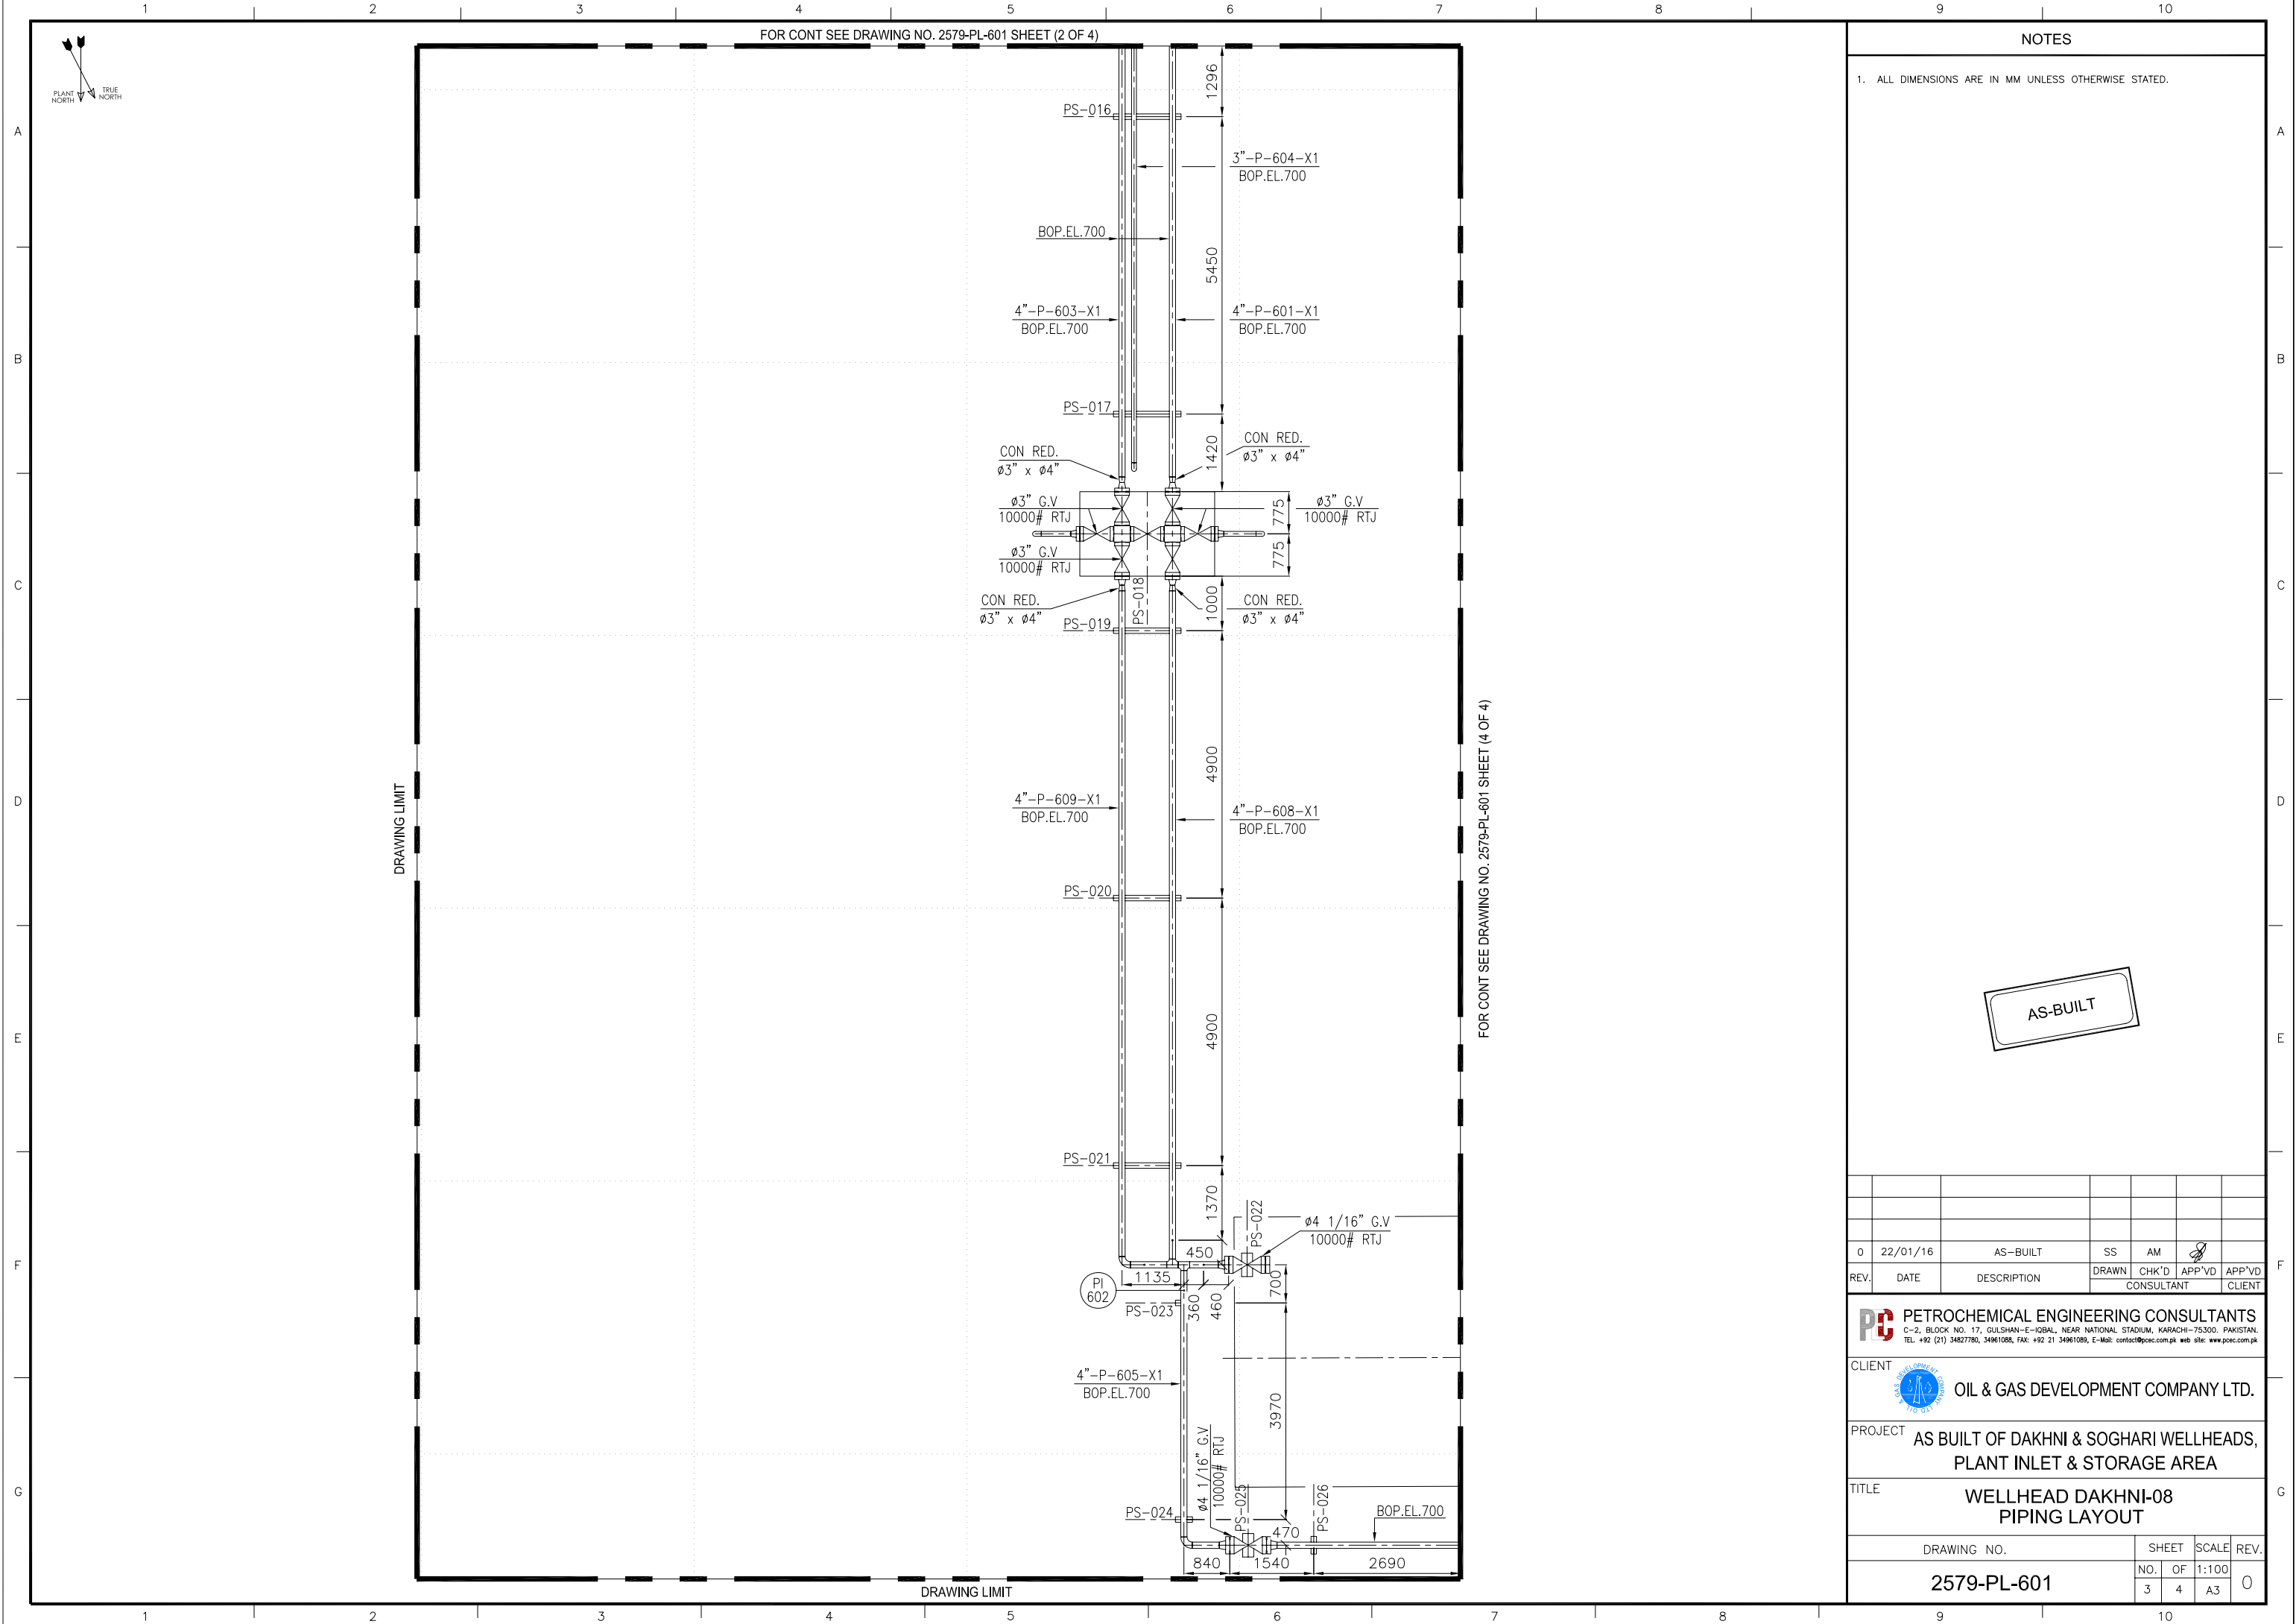


NOTES

1. ALL DIMENSIONS ARE IN MM UNLESS OTHERWISE STATED.

AS-BUILT

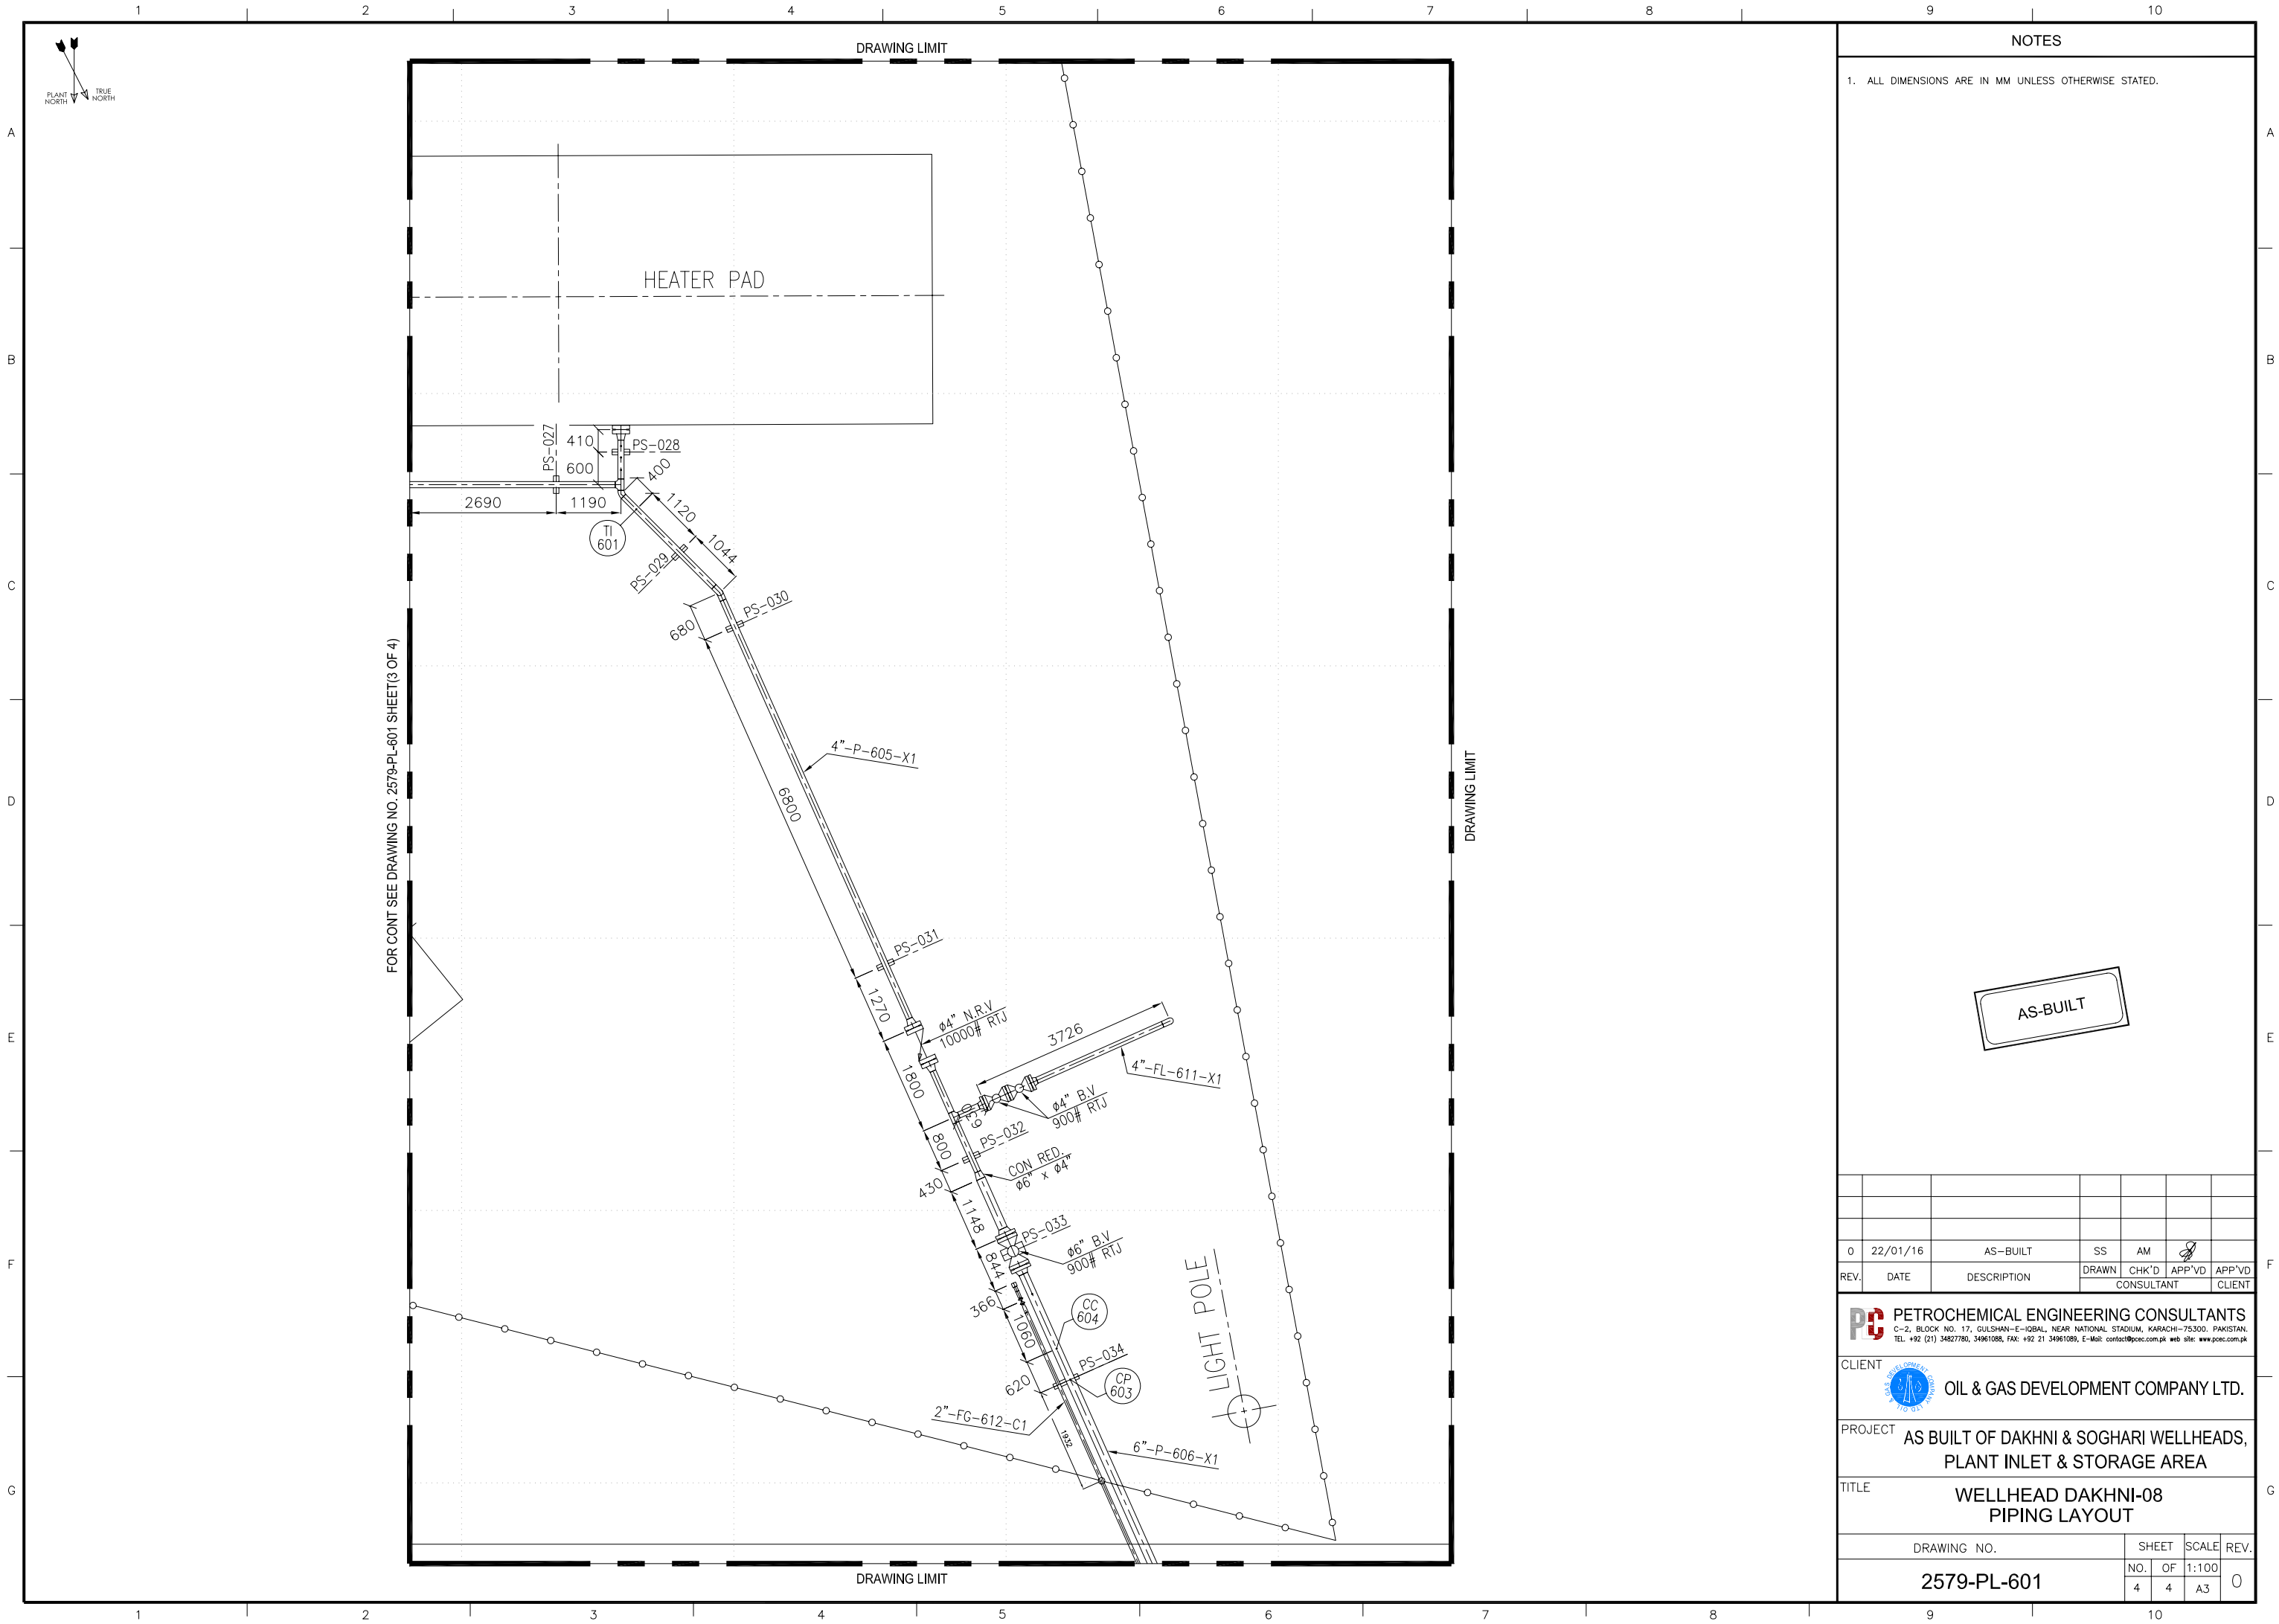


0	22/01/16	AS-BUILT	SS	AM			
REV.	DATE	DESCRIPTION	DRAWN	CHK'D	APP'VD	APP'VD	
			CONSULTANT			CLIENT	
<div><div></div><div><b>PETROCHEMICAL ENGINEERING CONSULTANTS</b> C-2, BLOCK NO. 17, GULSHAN-E-IOBAL, NEAR NATIONAL STADIUM, KARACHI-75300, PAKISTAN. TEL: +92 (21) 34827780, 34961088, FAX: +92 21 34961089, E-Mail: contact@pec.com.pk web site: www.pec.com.pk</div></div>							
CLIENT <div><div></div><div><b>OIL &amp; GAS DEVELOPMENT COMPANY LTD.</b></div></div>							
PROJECT <b>AS BUILT OF DAKHNI &amp; SOGHARI WELLHEADS, PLANT INLET &amp; STORAGE AREA</b>							
TITLE <b>WELLHEAD DAKHNI-08 PIPING LAYOUT</b>							
DRAWING NO.				SHEET	SCALE	REV.	
2579-PL-601				NO. OF	1:100	0	
				3	4	A3	



NOTES

1. ALL DIMENSIONS ARE IN MM UNLESS OTHERWISE STATED.

AS-BUILT

0	22/01/16	AS-BUILT	SS	AM																							
REV.	DATE	DESCRIPTION	DRAWN	CHK'D	APP'VD	APP'VD																					
			CONSULTANT			CLIENT																					
<div><div><div><div><b>PETROCHEMICAL ENGINEERING CONSULTANTS</b></div><div>C-2, BLOCK NO. 17, GULSHAN-E-IQBAL, NEAR NATIONAL STADIUM, KARACHI-75300, PAKISTAN.</div><div>TEL: +92 (21) 34827780, 34961088, FAX: +92 21 34961089, E-Mail: contact@pec.com.pk web site: www.pec.com.pk</div></div></div><div><div>CLIENT</div><div><div><div><div><b>OIL &amp; GAS DEVELOPMENT COMPANY LTD.</b></div></div></div></div><div><div>PROJECT</div><div>AS BUILT OF DAKHNI &amp; SOGHARI WELLHEADS, PLANT INLET &amp; STORAGE AREA</div></div><div><div>TITLE</div><div>WELLHEAD DAKHNI-08 PIPING LAYOUT</div></div></div><table><tr><td colspan="3">DRAWING NO.</td><td>SHEET</td><td>SCALE</td><td>REV.</td></tr><tr><td colspan="3">2579-PL-601</td><td>NO. OF</td><td>1:100</td><td></td></tr><tr><td colspan="3"></td><td>4 4</td><td>A3</td><td>0</td></tr></table></div>										DRAWING NO.			SHEET	SCALE	REV.	2579-PL-601			NO. OF	1:100					4 4	A3	0
DRAWING NO.			SHEET	SCALE	REV.																						
2579-PL-601			NO. OF	1:100																							
			4 4	A3	0																						