

NOTES


1. ALL DIMENSIONS ARE IN MM UNLESS OTHERWISE STATED.

EQUIPMENT LIST

NO.	DESCRIPTION
1	WELLHEAD DAKHNI-12
2	CORROSION INHIBITOR
3	GENERATOR
4	HYDRAULIC PANEL
5	HEATER

AS-BUILT

0	22/01/16	AS-BUILT	N.U	AM		
REV.	DATE	DESCRIPTION	DRAWN	CHK'D	APP'VD	APP'VD
			CONSULTANT		CONSULTANT	CLIENT
<div><div></div><div>PETROCHEMICAL ENGINEERING CONSULTANTS C-2, BLOCK NO. 17, GULSHAN-E-IOBAL, NEAR NATIONAL STADIUM, KARACHI-75300, PAKISTAN. TEL: +92 (21) 34827780, 34961088, FAX: +92 21 34961089, E-Mail: contact@pec.com.pk web site: www.pec.com.pk</div></div>						
CLIENT <div><div></div><div>OIL & GAS DEVELOPMENT COMPANY LTD.</div></div>						
PROJECT <div>AS BUILT OF DAKHNI & SOGHARI WELLHEADS, PLANT INLET & STORAGE AREA</div>						
TITLE <div>WELLHEAD DAKHNI-12 EQUIPMENT LAYOUT</div>						
DRAWING NO.			SHEET	SCALE	REV.	
2579-EL-701			NO. OF	1:310	0	
			1	1	A3	

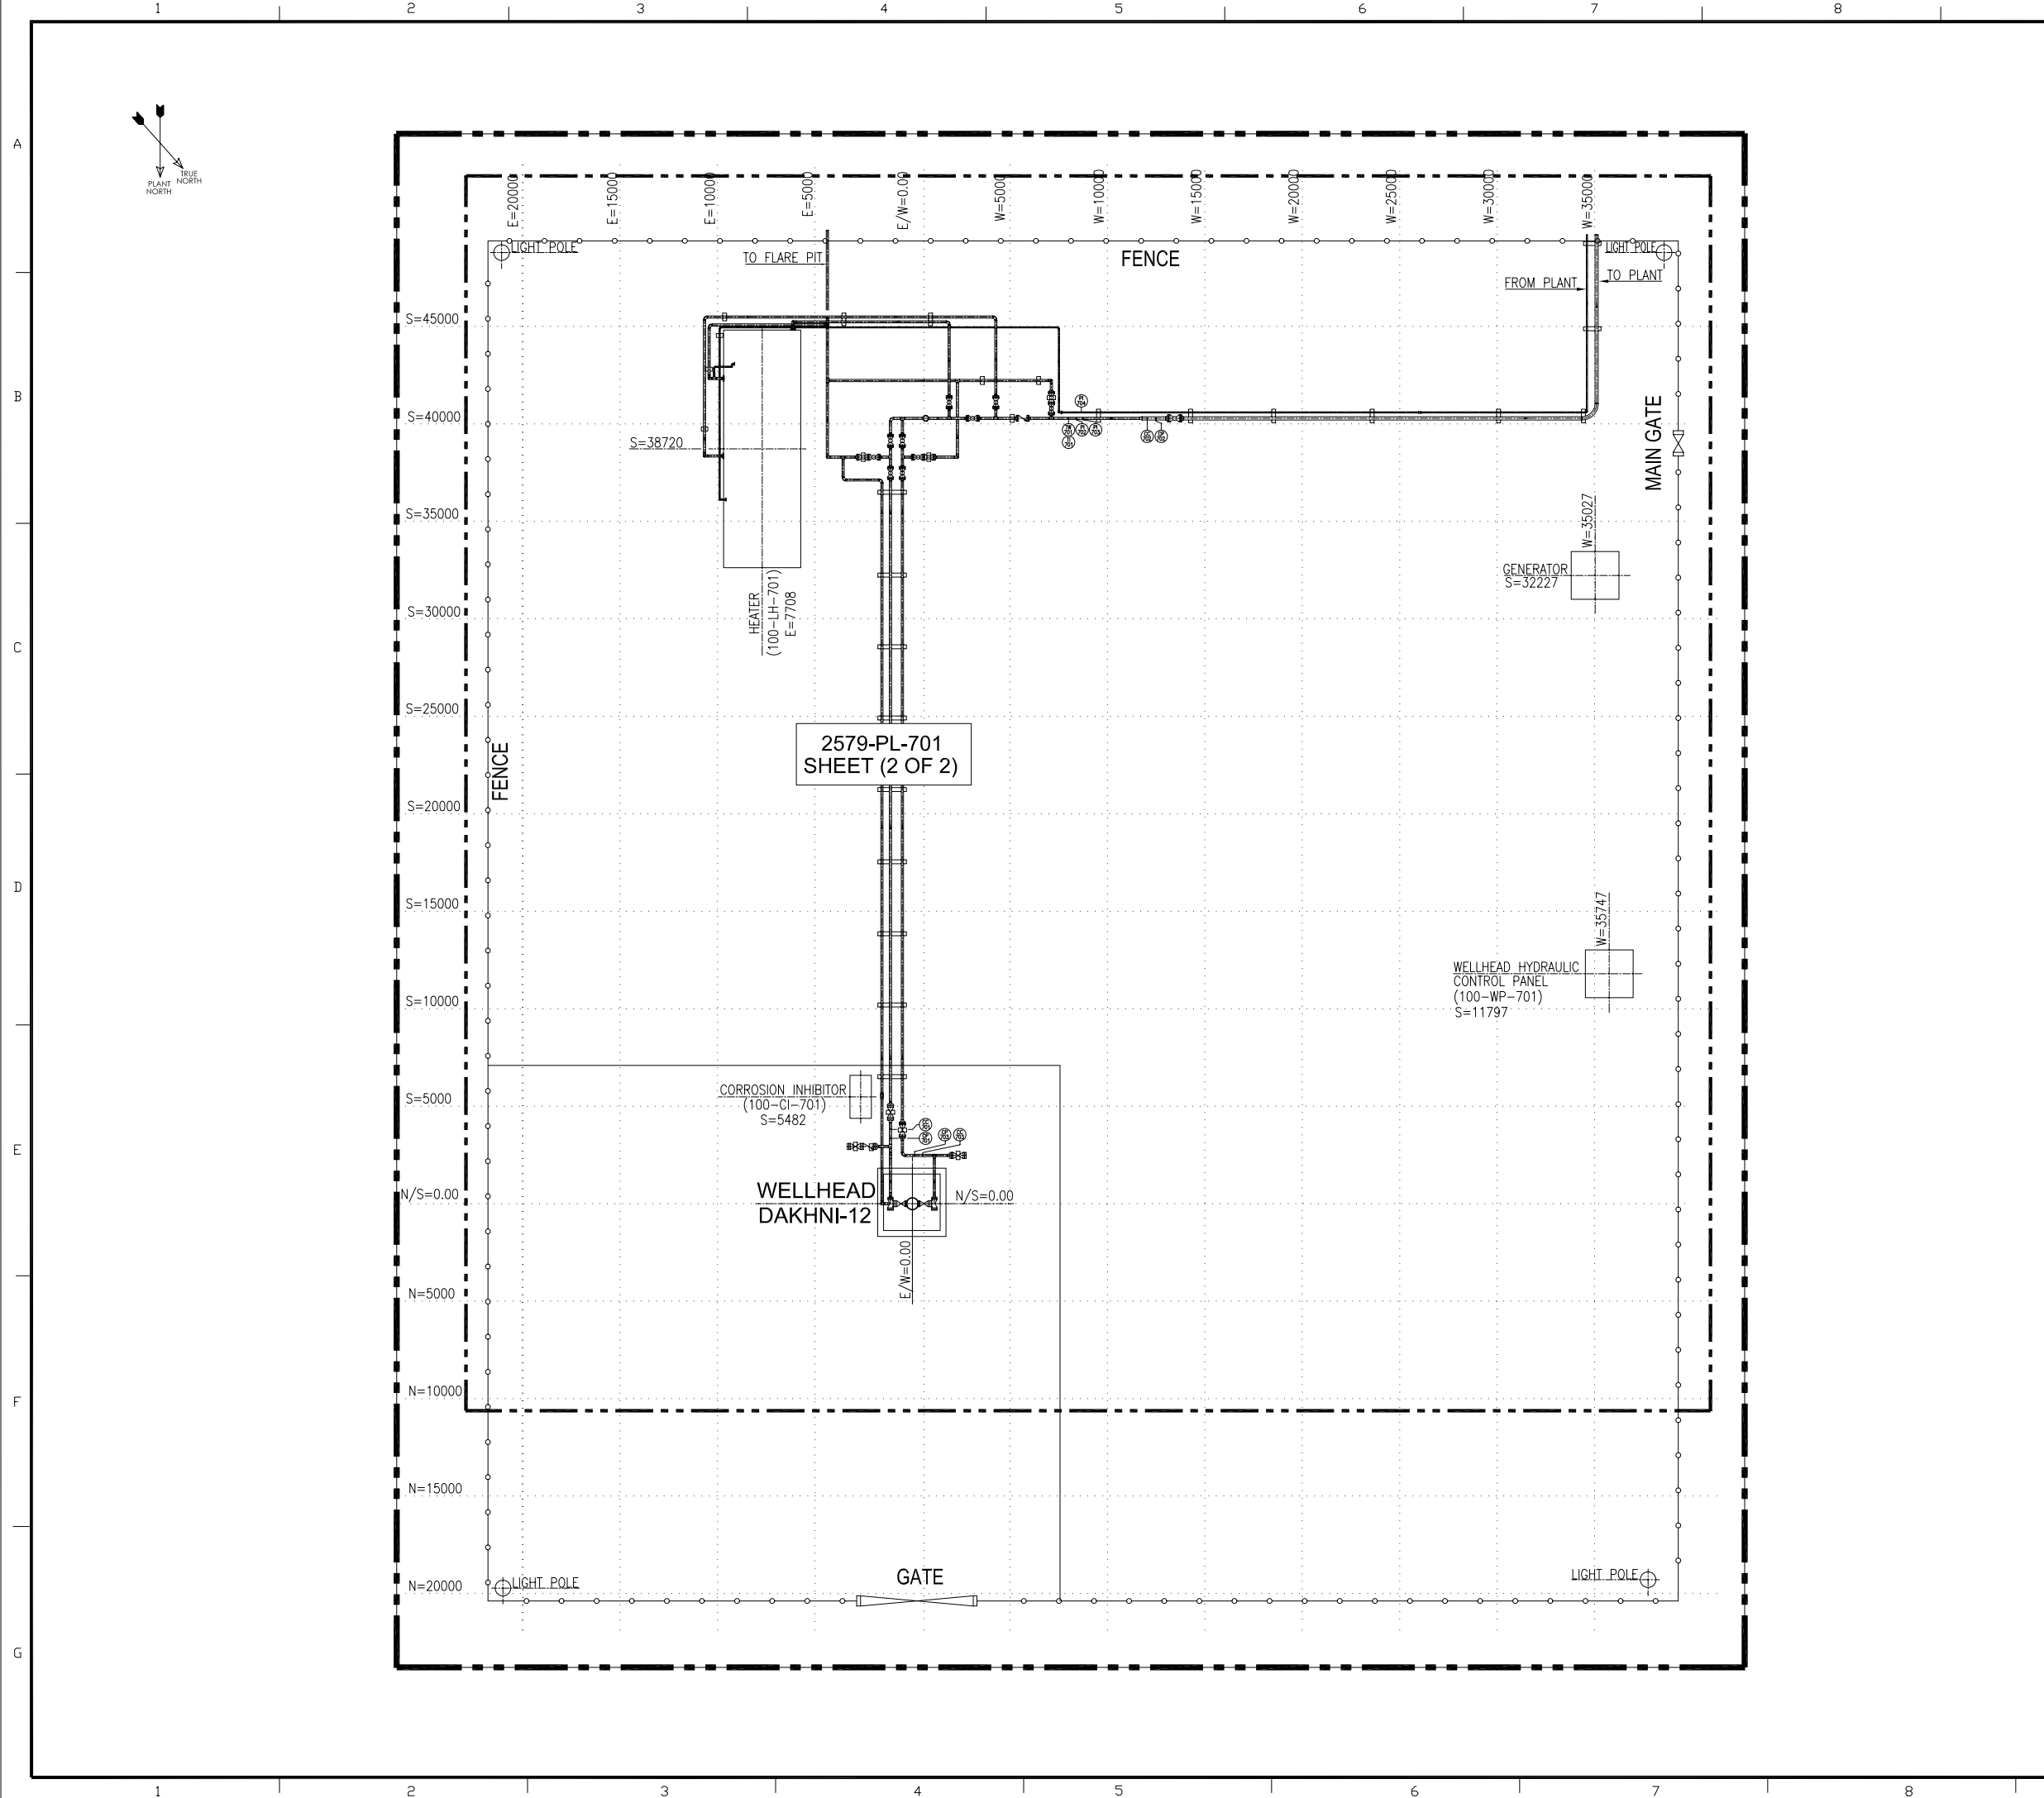

NOTES

1. ALL DIMENSIONS ARE IN MM UNLESS OTHERWISE STATED.

AS-BUILT

0	22/01/16	AS-BUILT	N.U	AM		
REV.	DATE	DESCRIPTION	DRAWN	CHK'D	APP'VD	APP'VD
			CONSULTANT		CONSULTANT	CLIENT

PC

PETROCHEMICAL ENGINEERING CONSULTANTS

C-2, BLOCK NO. 17, GULSHAN-E-IOBAL, NEAR NATIONAL STADIUM, KARACHI-75300, PAKISTAN.
TEL: +92 (21) 34827780, 34961088, FAX: +92 21 34961089, E-Mail: contact@pec.com.pk web site: www.pec.com.pk

CLIENT

OIL & GAS DEVELOPMENT COMPANY LTD.


PROJECT

AS BUILT OF DAKHNI & SOGHARI WELLHEADS,
PLANT INLET & STORAGE AREA

TITLE

WELLHEAD DAKHNI-12
KEY PLAN

DRAWING NO.	SHEET	SCALE	REV.
2579-PL-701	NO. OF	1:300	
	1 2	A3	0

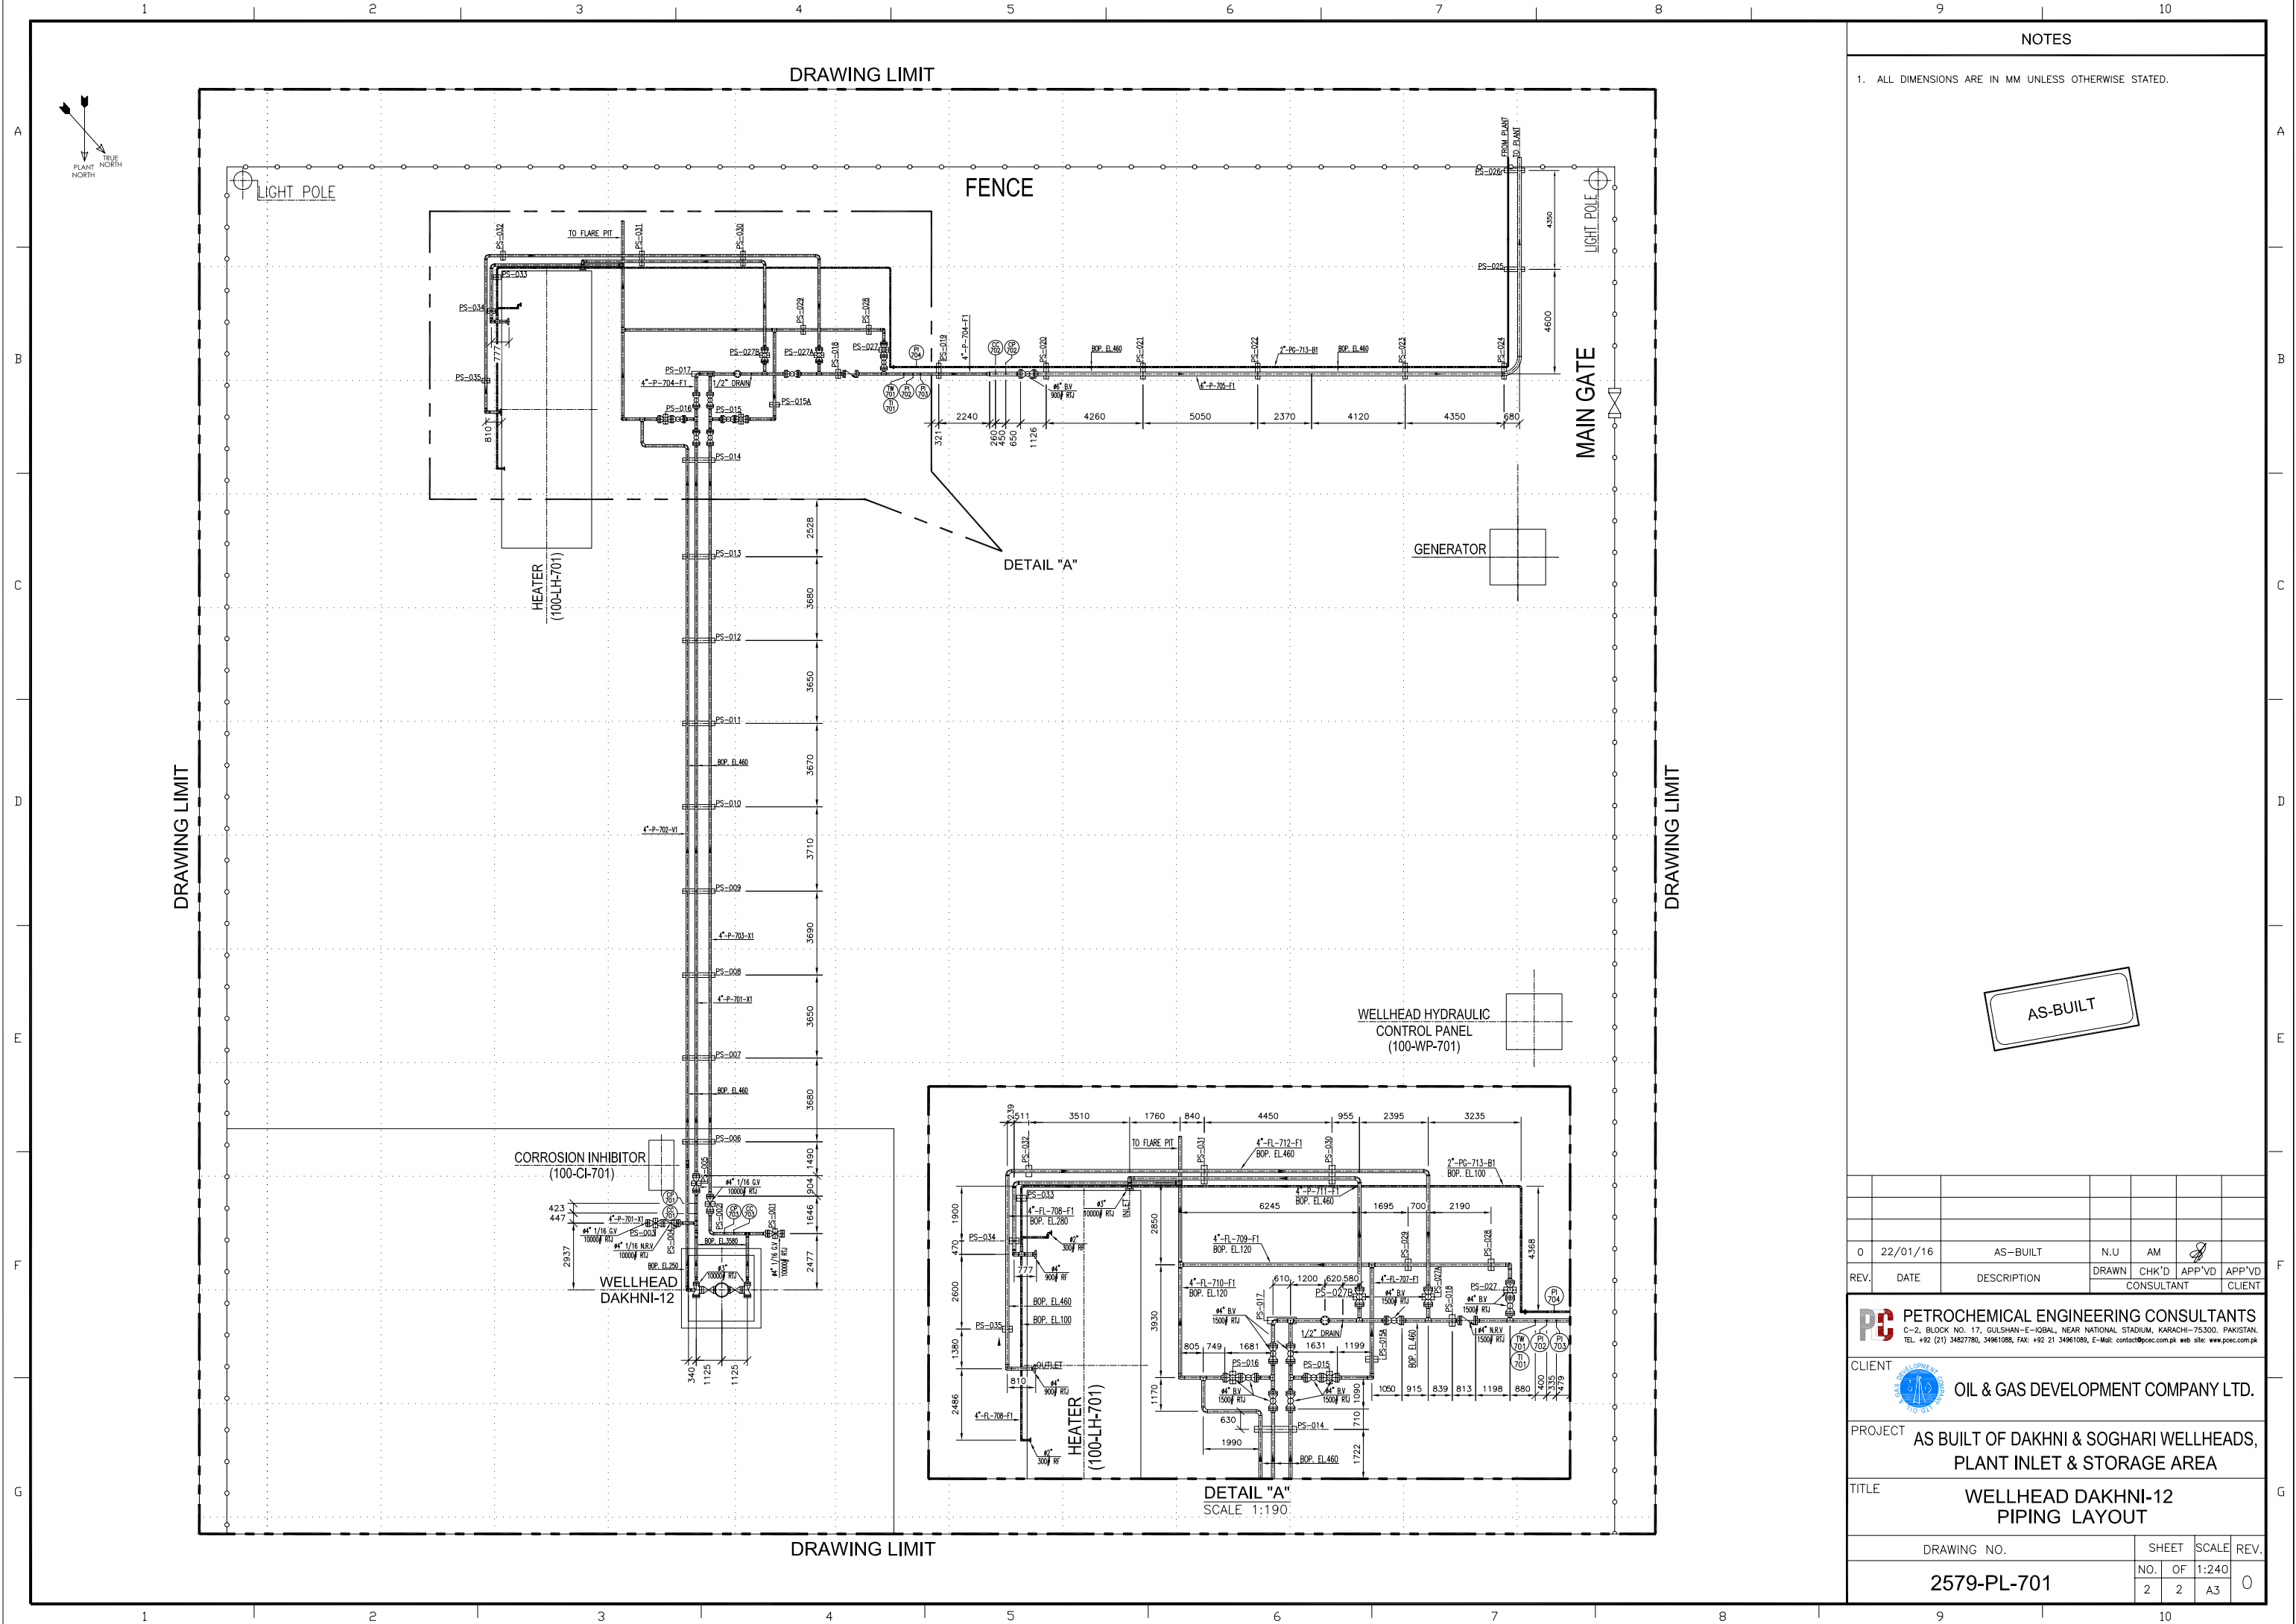

NOTES

1. ALL DIMENSIONS ARE IN MM UNLESS OTHERWISE STATED.

AS-BUILT

0	22/01/16	AS-BUILT	N.U	AM	
REV.	DATE	DESCRIPTION	DRAWN	CHK'D	APP'VD
			CONSULTANT		CLIENT
<div><div></div><div>PETROCHEMICAL ENGINEERING CONSULTANTS C-2, BLOCK NO. 17, GULSHAN-E-IOBAL, NEAR NATIONAL STADIUM, KARACHI-75300, PAKISTAN. TEL: +92 (21) 34827780, 34961088, FAX: +92 21 34961089, E-Mail: contact@pec.com.pk web site: www.pec.com.pk</div></div>					
CLIENT <div>OIL & GAS DEVELOPMENT COMPANY LTD.</div>					
PROJECT AS BUILT OF DAKHNI & SOGHARI WELLHEADS, PLANT INLET & STORAGE AREA					
TITLE WELLHEAD DAKHNI-12 PIPING LAYOUT					
DRAWING NO.			SHEET	SCALE	REV.
2579-PL-701			NO. OF	1:240	
			2	A3	0